


KEY PLAN
SCALE 1:10000

SAFETY, HEALTH AND ENVIRONMENTAL INFORMATION		WORKS STAGE
IN ADDITION TO THE HAZARDS/RISKS NORMALLY ASSOCIATED WITH THE TYPES OF WORK DETAILED ON THIS DRAWING, NOTE THE FOLLOWING:		C = CONSTRUCTION M = MAINTENANCE D = DECOMMISSION/DEMOLITION
HEALTH & SAFETY ▲		
HS/HS/001 - WORKS IN CLOSE PROXIMITY TO PUBLIC		C / M / D
HS/HS/002 - WORKING NEXT TO LIVE TRAFFIC		C / M / D
HS/HS/003 - WORKING NEXT TO STEEP EMBANKMENTS		C / M / D
HS/HS/004 - WORKING ON / NEXT TO EXISTING BRIDGE		C / M / D
HS/HS/005 - WORKING WITHIN EXISTING RIVER		C / M / D
HS/HS/006 - WORKING NEXT TO SMALL WATERCOURSE		C / M / D
HS/HS/007 - WORKING UNDER EXISTING OVERHEAD LINES		C / M / D
ENVIRONMENTAL ▲		
HS/SE/001 - WORKS IN CLOSE PROXIMITY TO EXISTING TREE ROOT PROTECTION ZONES		C / D
HS/SE/002 - VEGETATION CLEARANCE - POTENTIAL FOR HABITAT DISTURBANCE		C / D
HS/SE/003 - VEGETATION CLEARANCE - POTENTIAL FOR PROTECTED SPECIES		C / D
UTILITIES ▲		
HS/SU/001 - EXISTING UTILITIES		C / M / D

IT IS ASSUMED THAT ALL WORKS WILL BE CARRIED OUT BY A COMPETENT CONTRACTOR WORKING, WHERE APPROPRIATE, TO AN APPROVED METHOD STATEMENT. TO BE READ IN CONJUNCTION WITH RISK REGISTER FOR FURTHER INFORMATION AND MITIGATION MEASURES.

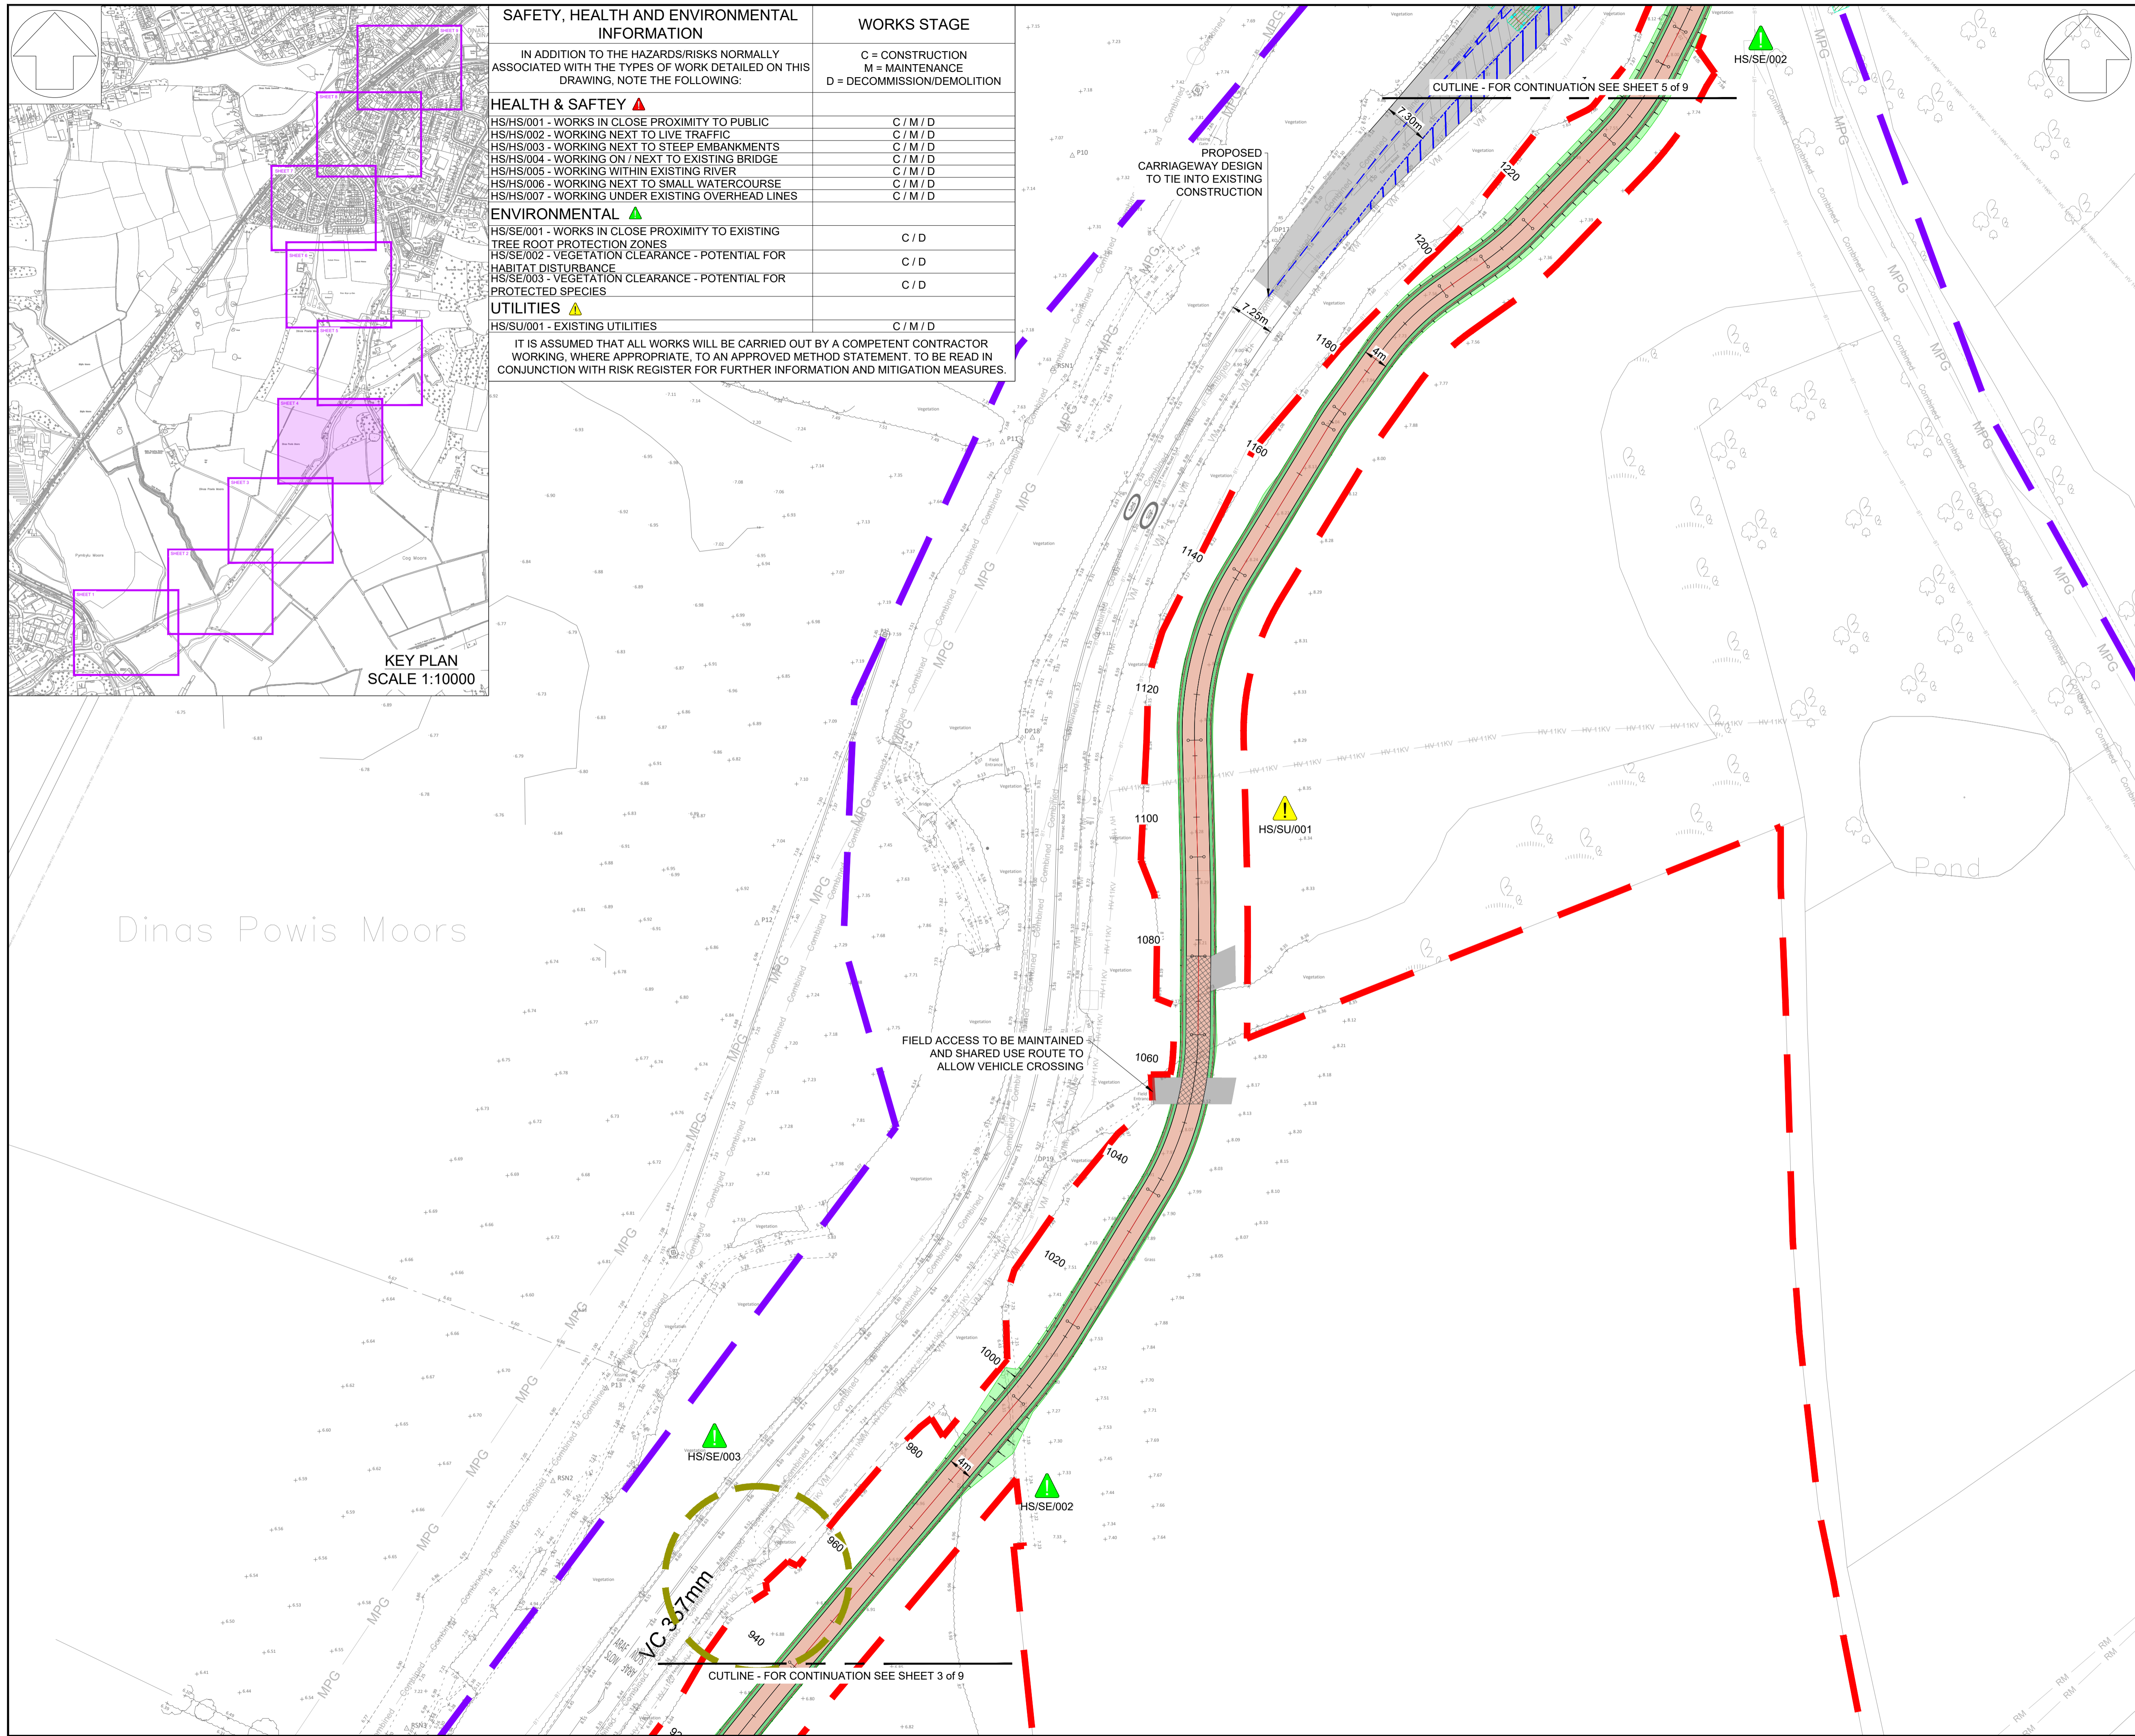

- NOTES**
- DO NOT SCALE FROM DRAWING. USE FIGURED DIMENSIONS ONLY. ALL UNITS ARE IN METERS UNLESS STATED OTHERWISE.
 - REFER TO DRAWING 10058585-ARC-XX-010-DR-C-00004 FOR GENERAL ARRANGEMENT OVERVIEW.
 - REFER TO DRAWING 10058585-ARC-XX-010-DR-C-00019 FOR SITE LOCATION PLAN.
 - REFER TO DRAWING 10058585-ARC-XX-010-DR-C-00039-00040 FOR EXISTING SITE PLANS.
 - REFER TO DRAWING 10058585-ARC-XX-072-DR-C-00001 FOR TYPICAL CROSS SECTIONS.
 - REFER TO DRAWINGS 10058585-ARC-XX-130-DR-C-00001-00009 FOR PROPOSED STREET LIGHTING LAYOUTS.
 - REFER TO REPORT 10058585-ARC-AT-300-RP-E-00002 FOR POTENTIAL PROTECTED SPECIES PATH LOCATIONS.

KEY

	PLANNING BOUNDARY
	PROPOSED SHARED FOOTWAY/CYCLEWAY
	CARRIAGEWAY
	PROPOSED EARTHWORKS
	PROPOSED VERGE
	PROPOSED ROAD MARKINGS
	SUITABLE HEAVY VEHICLE CROSSOVER
	POTENTIAL PROTECT SPECIES PATH LOCATION (SEE NOTE 4)
	EXISTING GRAVEL PATH
	PUBLIC RIGHT OF WAY
	PROPOSED POST AND RAIL FENCE

Rev	Date	Description	Prod.	Chk.	Rev.	App.
P01	11/11/24	FIRST ISSUE		GJ	SD	MG

VALE OF GLAMORGAN
BRO MORGANNWG

Project: **Biglis to Dinas Powys ATR**

Site	Client
Biglis to Dinas Powys Cardiff	Vale of Glamorgan Council Civic Offices, Hollon Rd, Barry CF63 4RU www.valeofglamorgan.gov.uk

ARCADIS

Registered office: 80 Fenchurch Street, London EC3M 4BY

Coordinating office: Arcadis Suite 4d, 4th Floor, Hodge House, 144-166 St Mary St, Cardiff CF10 1DY. Tel: 44 (0)29 2092 6700

www.arcadis.com © Copyright reserved

GENERAL ARRANGEMENT SHEET 4 OF 9

Designed:	Signed:	Date:
G. Jones	Digitally Signed	29/08/24
Produced:	Signed	Date
G. Jones	Digitally Signed	08/11/24
Checked:	Signed	Date
S. Davies	Digitally Signed	08/11/24
Reviewed:	Signed	Date
M. Griffiths	Digitally Signed	11/11/24
Approved:	Signed	Date
M. Griffiths	Digitally Signed	11/11/24

Design Stage: Preliminary Design

Original Size:	Grid:	Datum:
A1	OS	ODN

Suitability Code: S1 Scale: 1:500 Project Number: 10058585

Suitability Description: Suitable for Coordination

Drawing Number:	Revision:
10058585 - ARC - XX - 010 - DR - C - 00008	P01