


- NOTES**
- DO NOT SCALE FROM DRAWING. USE FIGURED DIMENSIONS ONLY.
 - ALL UNITS ARE IN METERS UNLESS STATED OTHERWISE.
 - REFER TO DRAWING 10058585-ARC-XX-010-DR-C-00004 FOR GENERAL ARRANGEMENT OVERVIEW.
 - REFER TO DRAWING 10058585-ARC-XX-010-DR-C-00019 FOR SITE LOCATION PLAN.
 - REFER TO DRAWING 10058585-ARC-XX-010-DR-C-00039-00040 FOR EXISTING SITE PLANS.
 - REFER TO DRAWING 10058585-ARC-XX-072-DR-C-00001 FOR TYPICAL CROSS SECTIONS.
 - REFER TO DRAWINGS 10058585-ARC-XX-130-DR-C-00001-00009 FOR PROPOSED STREET LIGHTING LAYOUTS.
- KEY**
- PLANNING BOUNDARY
 - PROPOSED SHARED FOOTWAY/CYCLEWAY
 - FOOTWAY
 - CARRIAGEWAY
 - PROPOSED VEHICLE CROSSOVER
 - PROPOSED EARTHWORKS
 - PROPOSED VERGE
 - PROPOSED BLISTER TACTILE PAVING
 - PROPOSED LADDER TACTILE PAVING
 - PROPOSED CONTROLLED CROSSING BLISTER TACTILE PAVING
 - PROPOSED ROAD MARKINGS
 - SUITABLE HEAVY VEHICLE CROSSOVER
 - EXISTING GRAVEL TRACK
 - VISIBILITY SPLAYS
 - PUBLIC RIGHT OF WAY
 - PROPOSED POST AND RAIL FENCE

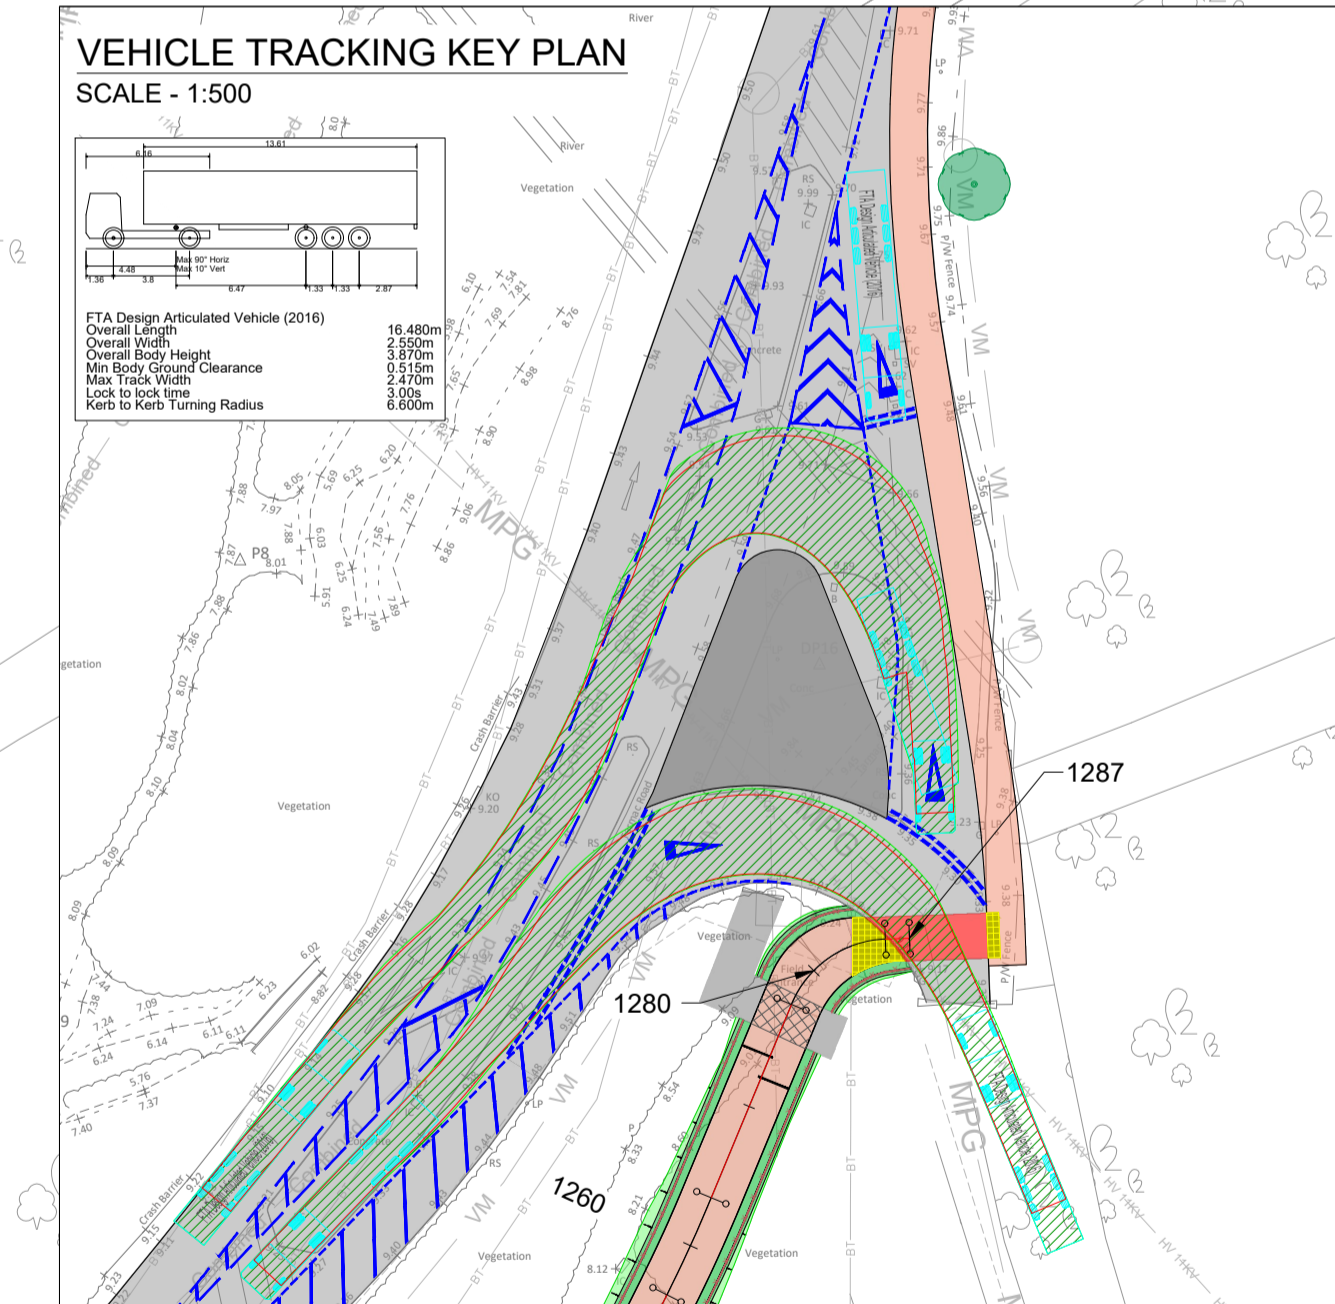

SAFETY, HEALTH AND ENVIRONMENTAL INFORMATION		WORKS STAGE	
IN ADDITION TO THE HAZARDS/RISKS NORMALLY ASSOCIATED WITH THE TYPES OF WORK DETAILED ON THIS DRAWING, NOTE THE FOLLOWING:		C = CONSTRUCTION M = MAINTENANCE D = DECOMMISSION/DEMOLITION	
HEALTH & SAFETY			
HS/HS/001 - WORKS IN CLOSE PROXIMITY TO PUBLIC	C / M / D		
HS/HS/002 - WORKING NEXT TO LIVE TRAFFIC	C / M / D		
HS/HS/003 - WORKING NEXT TO STEEP EMBANKMENTS	C / M / D		
HS/HS/004 - WORKING ON / NEXT TO EXISTING BRIDGE	C / M / D		
HS/HS/005 - WORKING WITHIN EXISTING RIVER	C / M / D		
HS/HS/006 - WORKING NEXT TO SMALL WATERCOURSE	C / M / D		
HS/HS/007 - WORKING UNDER EXISTING OVERHEAD LINES	C / M / D		
ENVIRONMENTAL			
HS/SE/001 - WORKS IN CLOSE PROXIMITY TO EXISTING TREE ROOT PROTECTION ZONES	C / D		
HS/SE/002 - VEGETATION CLEARANCE - POTENTIAL FOR HABITAT DISTURBANCE	C / D		
HS/SE/003 - VEGETATION CLEARANCE - POTENTIAL FOR PROTECTED SPECIES	C / D		
UTILITIES			
HS/SU/001 - EXISTING UTILITIES	C / M / D		
IT IS ASSUMED THAT ALL WORKS WILL BE CARRIED OUT BY A COMPETENT CONTRACTOR WORKING, WHERE APPROPRIATE, TO AN APPROVED METHOD STATEMENT. TO BE READ IN CONJUNCTION WITH RISK REGISTER FOR FURTHER INFORMATION AND MITIGATION MEASURES.			

PO1	11/11/24	FIRST ISSUE	GJ	SD	MG	MG
Rev	Date	Description	Prod.	Chk.	Rev.	App.

VALE OF GLAMORGAN
BRO MORGANNIWG

Project: **Biglis to Dinas Powys ATR**

Site: Biglis to Dinas Powys Cardiff
Client: Vale of Glamorgan Council Civic Offices, Holford Rd, Barry CF83 4RU, www.valeofglamorgan.gov.uk

ARCADIS

Registered office: 80 Fenchurch Street, London EC3M 4BY
Coordinating office: Arcadis Suite 4d, 4th Floor, Hodge House, 144-166 St Mary St, Cardiff CF10 1DY, Tel: 44 (0)29 2092 6700

www.arcadis.com © Copyright reserved

Drawing Title: **GENERAL ARRANGEMENT SHEET 5 OF 9**

Designed: G.Jones	Signed: Digitally Signed	Date: 29/08/24
Produced: G.Jones	Signed: Digitally Signed	Date: 08/11/24
Checked: S.Davies	Signed: Digitally Signed	Date: 08/11/24
Reviewed: M.Griffiths	Signed: Digitally Signed	Date: 11/11/24
Approved: M.Griffiths	Signed: Digitally Signed	Date: 11/11/24

Design Stage: Preliminary Design
Original Size: A1
Grid: OS
Datum: ODN
Suitability Code: S1
Scale: 1:500
Project Number: 10058585

Suitable for Coordination

Drawing Number: 10058585 - ARC - XX - 010 - DR - C - 00009
Revision: P01