


KEY PLAN
SCALE 1:10000

SAFETY, HEALTH AND ENVIRONMENTAL INFORMATION	WORKS STAGE
IN ADDITION TO THE HAZARDS/RISKS NORMALLY ASSOCIATED WITH THE TYPES OF WORK DETAILED ON THIS DRAWING, NOTE THE FOLLOWING:	C = CONSTRUCTION M = MAINTENANCE D = DECOMMISSION/DEMOLITION
HEALTH & SAFETY ▲	
HS/HS/001 - WORKS IN CLOSE PROXIMITY TO PUBLIC	C / M / D
HS/HS/002 - WORKING NEXT TO LIVE TRAFFIC	C / M / D
HS/HS/003 - WORKING NEXT TO STEEP EMBANKMENTS	C / M / D
HS/HS/004 - WORKING ON / NEXT TO EXISTING BRIDGE	C / M / D
HS/HS/005 - WORKING WITHIN EXISTING RIVER	C / M / D
HS/HS/006 - WORKING NEXT TO SMALL WATERCOURSE	C / M / D
HS/HS/007 - WORKING UNDER EXISTING OVERHEAD LINES	C / M / D
ENVIRONMENTAL ▲	
HS/SE/001 - WORKS IN CLOSE PROXIMITY TO EXISTING TREE ROOT PROTECTION ZONES	C / D
HS/SE/002 - VEGETATION CLEARANCE - POTENTIAL FOR HABITAT DISTURBANCE	C / D
HS/SE/003 - VEGETATION CLEARANCE - POTENTIAL FOR PROTECTED SPECIES	C / D
UTILITIES ▲	
HS/SU/001 - EXISTING UTILITIES	C / M / D

IT IS ASSUMED THAT ALL WORKS WILL BE CARRIED OUT BY A COMPETENT CONTRACTOR WORKING, WHERE APPROPRIATE, TO AN APPROVED METHOD STATEMENT. TO BE READ IN CONJUNCTION WITH RISK REGISTER FOR FURTHER INFORMATION AND MITIGATION MEASURES.

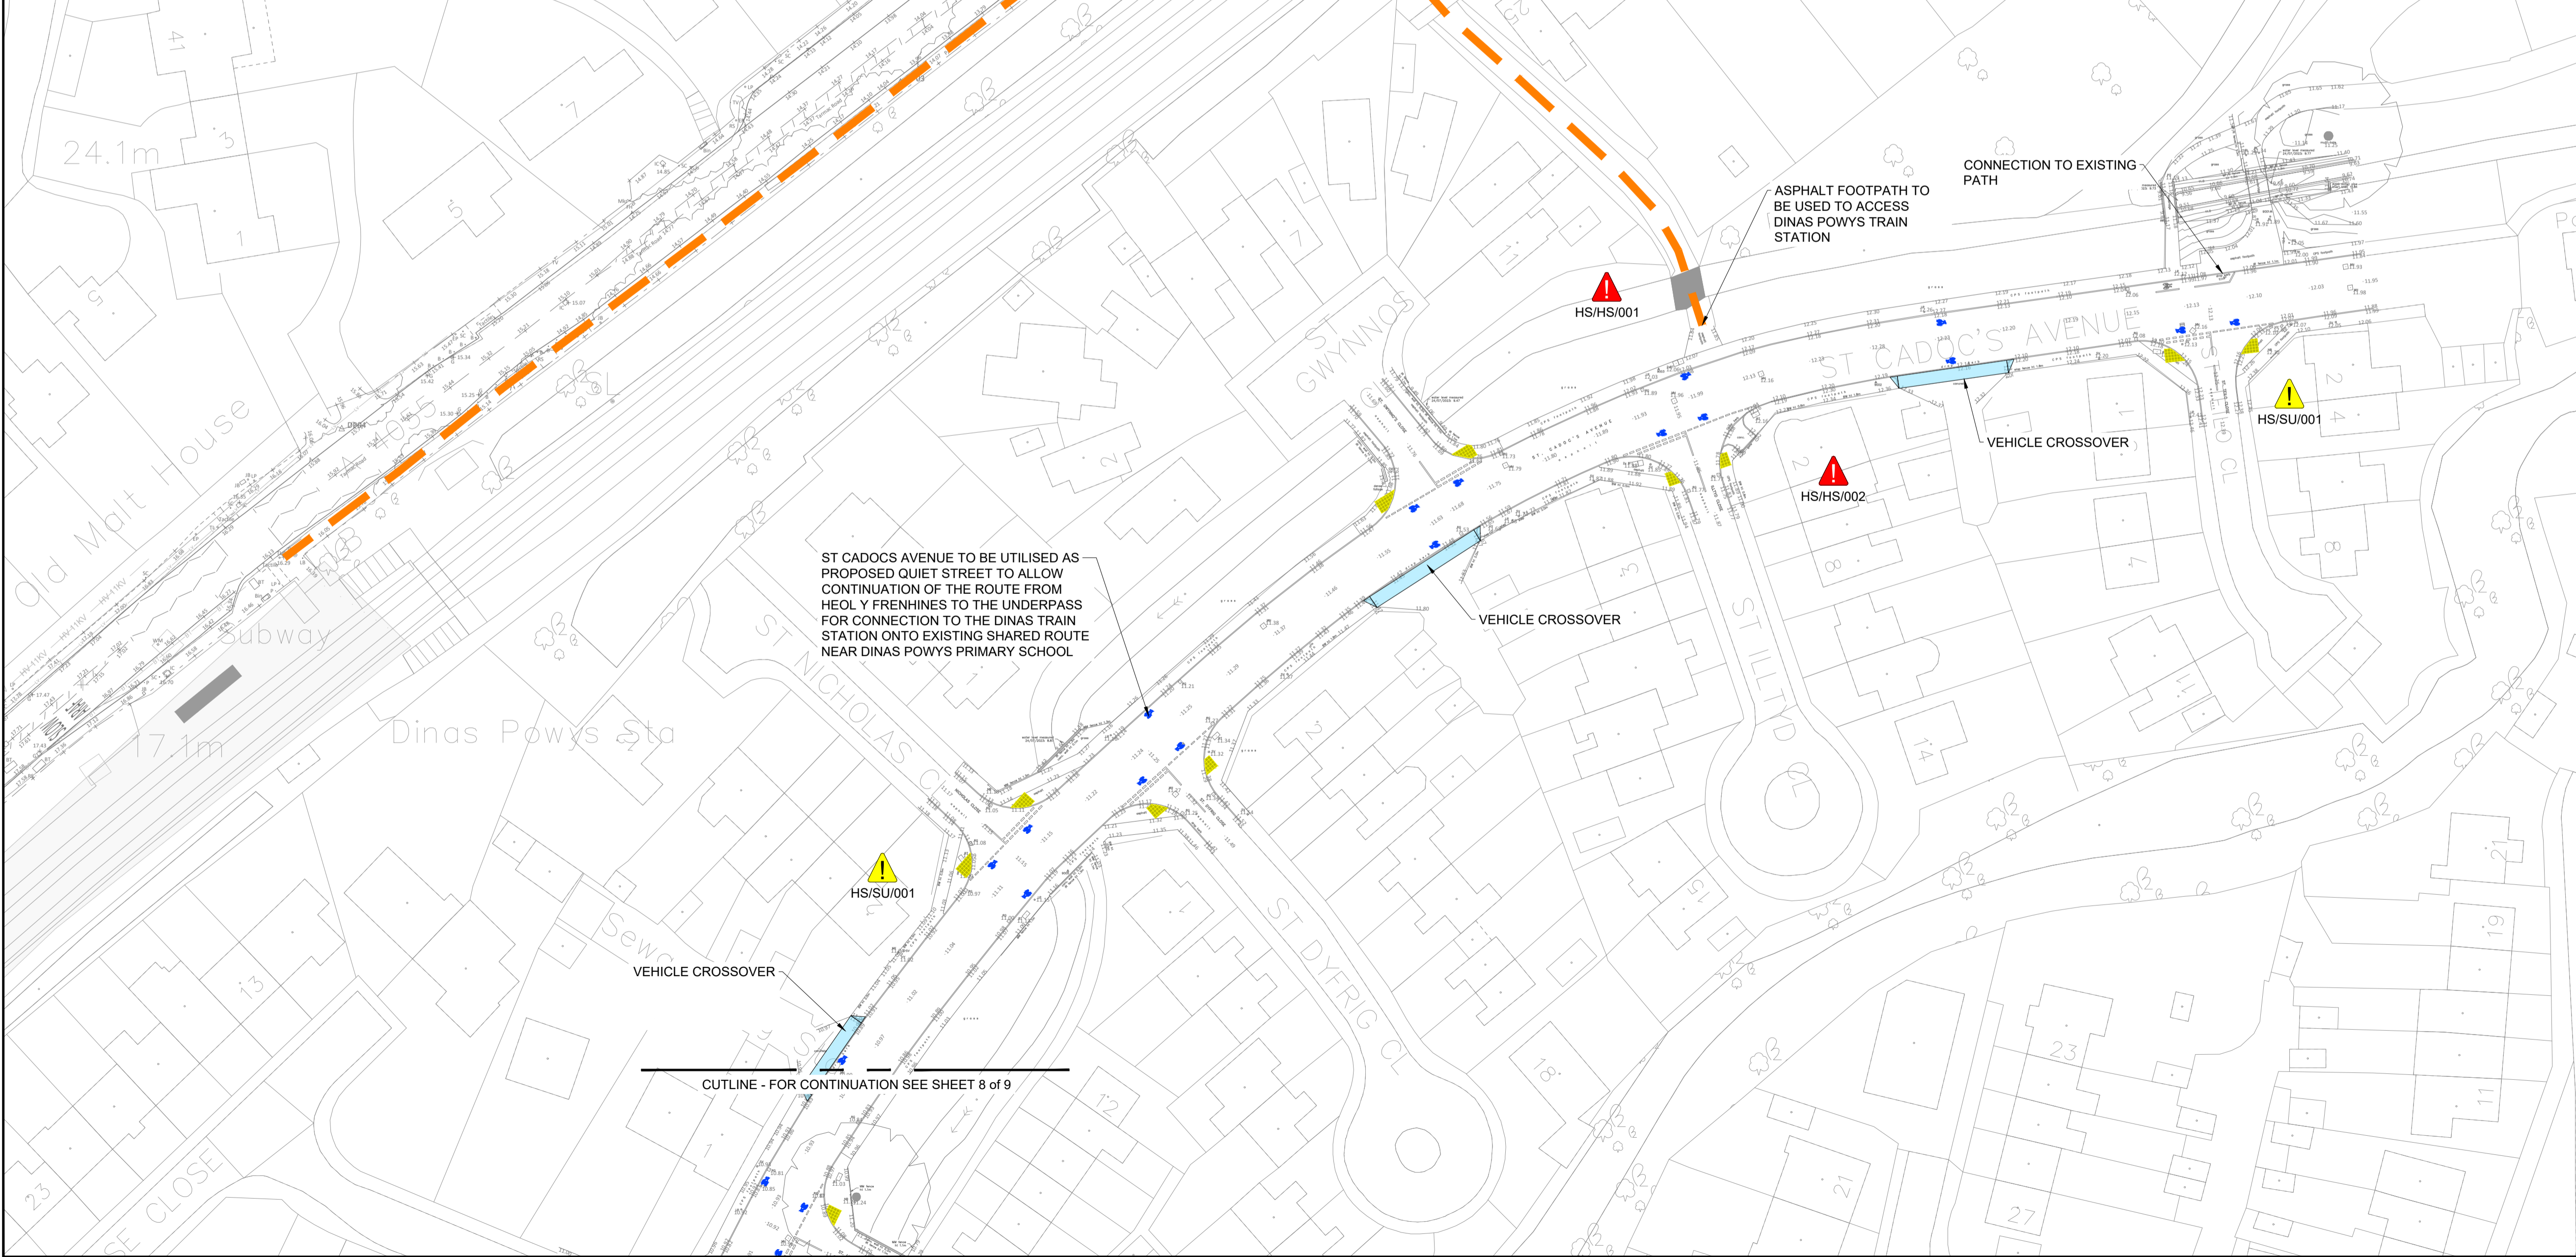

ST CADOC'S AVENUE TO BE UTILISED AS PROPOSED QUIET STREET TO ALLOW CONTINUATION OF THE ROUTE FROM HEOL Y FRENHINES TO THE UNDERPASS FOR CONNECTION TO THE DINAS TRAIN STATION ONTO EXISTING SHARED ROUTE NEAR DINAS POWYS PRIMARY SCHOOL

EXISTING ROUTE TO BE USED TO ACCESS DINAS POWYS TRAIN STATION

ASPHALT FOOTPATH TO BE USED TO ACCESS DINAS POWYS TRAIN STATION

CONNECTION TO EXISTING PATH

VEHICLE CROSSOVER

VEHICLE CROSSOVER

VEHICLE CROSSOVER

CUTLINE - FOR CONTINUATION SEE SHEET 8 of 9

- NOTES
- DO NOT SCALE FROM DRAWING. USE FIGURED DIMENSIONS ONLY. ALL UNITS ARE IN METERS UNLESS STATED OTHERWISE.
 - REFER TO DRAWING 10058585-ARC-XX-010-DR-C-00004 FOR GENERAL ARRANGEMENT OVERVIEW.
 - REFER TO DRAWING 10058585-ARC-XX-010-DR-C-00019 FOR SITE LOCATION PLAN.
 - REFER TO DRAWING 10058585-ARC-XX-010-DR-C-00039-00040 FOR EXISTING SITE PLANS.
 - REFER TO DRAWING 10058585-ARC-XX-072-DR-C-00001 FOR TYPICAL CROSS SECTIONS.
 - REFER TO DRAWINGS 10058585-ARC-XX-130-DR-C-00001-00009 FOR PROPOSED STREET LIGHTING LAYOUTS.

KEY

	PROPOSED VEHICLE CROSSOVER
	PROPOSED BLISTER TACTILE PAVING
	PROPOSED ROAD MARKINGS

Rev	Date	Description	Prod.	Chk.	Rev.	App.
P01	11/11/24	FIRST ISSUE				

VALE OF GLAMORGAN
BRO MORGANNWG

Project: Biglis to Dinás Powys ATR

Site: Biglis to Dinás Powys Cardiff
Client: Vale of Glamorgan Council Civic Offices, Holton Rd, Barry CF83 4RU www.valeofglamorgan.gov.uk

ARCADIS

Registered office: 80 Fenchurch Street London EC3M 4BY
Coordinating office: Arcadis Suite 4d, 4th Floor, Hodge House 144-166 St Mary St, Cardiff CF10 1DY Tel: 44 (0)29 2092 6700

www.arcadis.com © Copyright reserved

GENERAL ARRANGEMENT SHEET 9 OF 9

Designed	Signed	Date
G.Jones	Digitally Signed	29/08/24
G.Jones	Digitally Signed	08/11/24
S.Davies	Digitally Signed	08/11/24
M.Griffiths	Digitally Signed	11/11/24
M.Griffiths	Digitally Signed	11/11/24

Design Stage: Preliminary Design

Original Size	Grid	Datum
A1	OS	ODN

Suitability Code: S1 Scale: 1:500 Project Number: 10058585

Suitable for Coordination

Drawing Number	Revision
10058585 - ARC - XX - 010 - DR - C - 00013	P01