
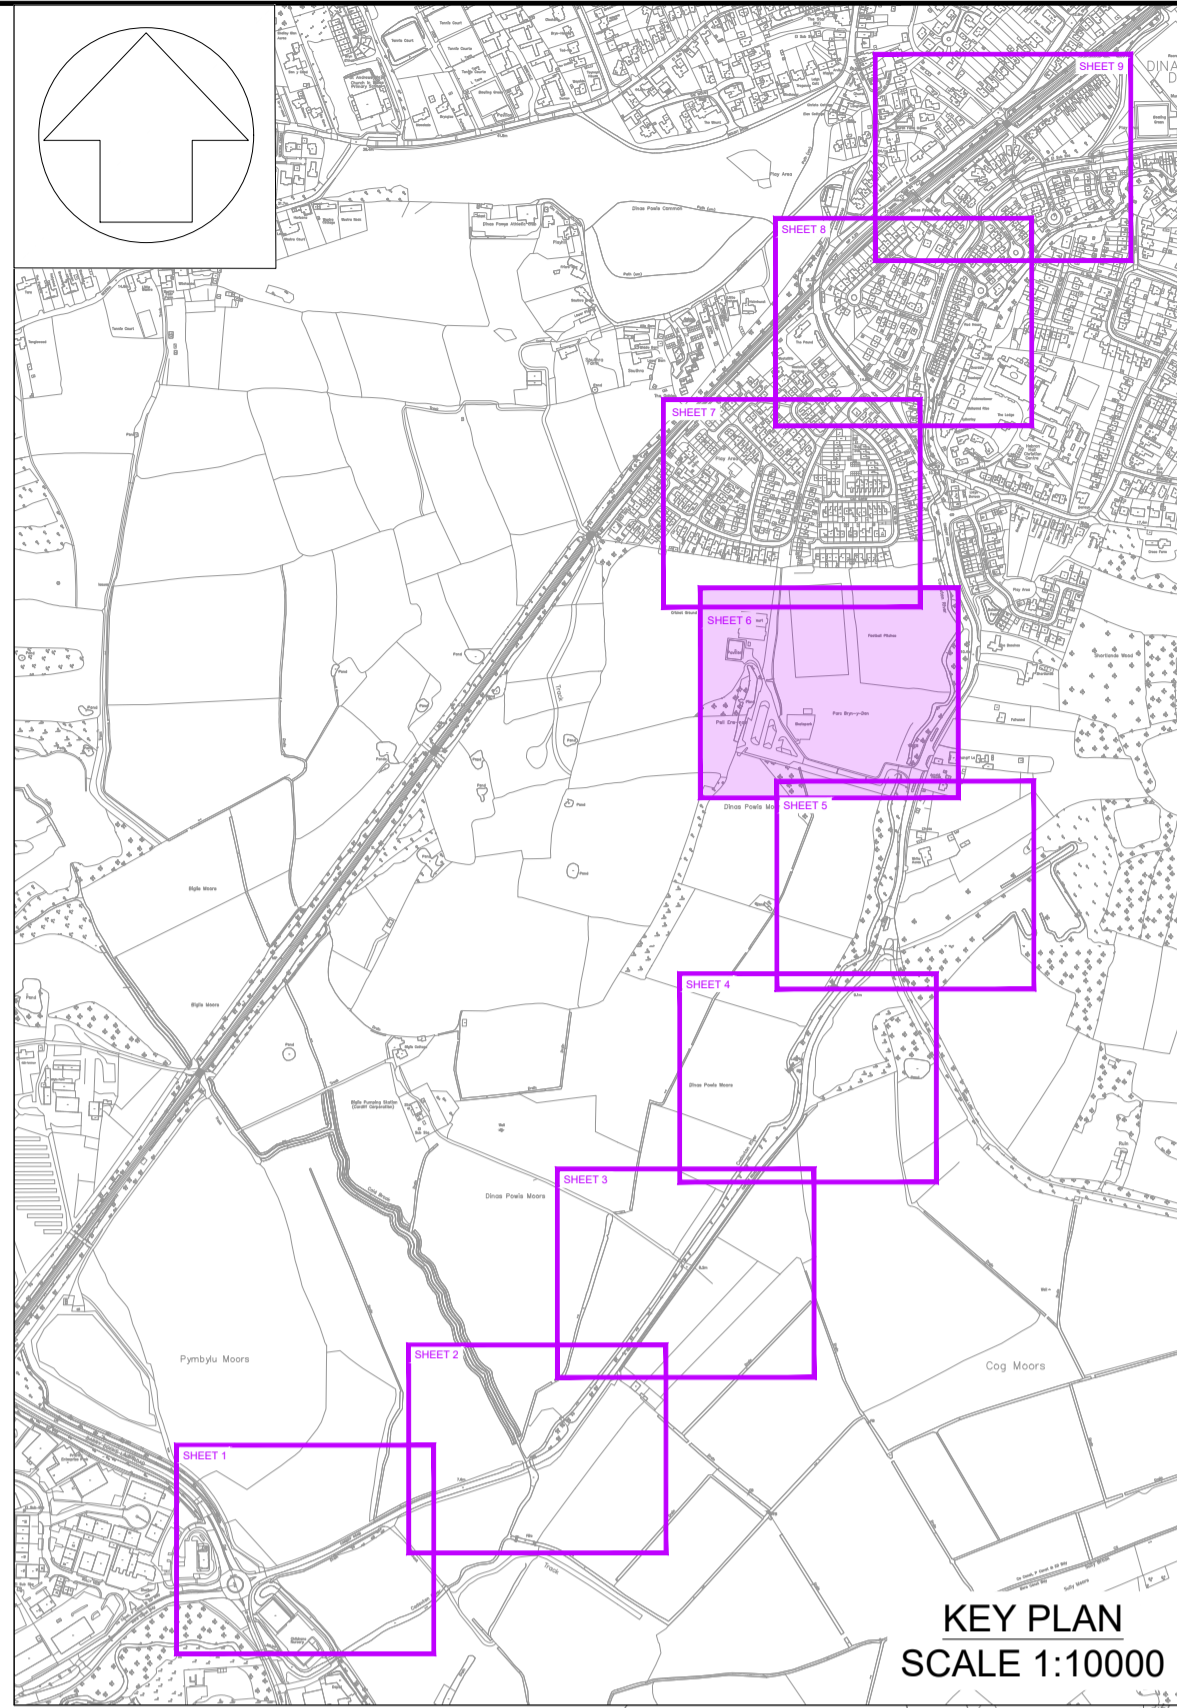


CUTLINE - FOR CONTINUATION SEE SHEET 7 of 9

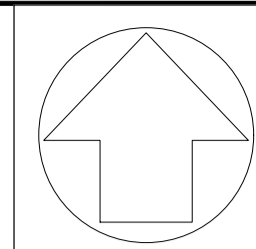

KEY PLAN
SCALE 1:10000

- NOTES**
- DO NOT SCALE FROM DRAWING. USE FIGURED DIMENSIONS ONLY.
 - ALL UNITS ARE IN METERS UNLESS STATED OTHERWISE.
 - REFER TO DRAWINGS 10058585-ARC-XX-010-DR-C-00004-00013 FOR GENERAL ARRANGEMENT LAYOUTS
- KEY**
- PROPOSED SHARED FOOTWAY/CYCLEWAY
 - CARRIAGEWAY
 - PROPOSED EARTHWORKS
 - PROPOSED VERGE
 - PROPOSED VEHICLE CROSSOVER
 - PROPOSED RAISED TABLE
 - PROPOSED POST AND RAIL FENCE
 - EXISTING 10m LIGHTING COLUMN TO BE RETAINED
 - EXISTING 10m LIGHTING COLUMN TO BE REMOVED DUE TO CONFLICTING WITH THE PROPOSED ALIGNMENT
 - PROPOSED 10m LIGHTING COLUMN TO REPLACE EXISTING LIGHTING COLUMN.
 - PROPOSED 5m LIGHTING COLUMN.
 - LIGHTING CONTOUR 0.2 LUX
 - LIGHTING CONTOUR 0.5 LUX
 - LIGHTING CONTOUR 1.0 LUX
 - LIGHTING CONTOUR 5.0 LUX
 - LIGHTING CONTOUR 10.0 LUX
 - LIGHTING CONTOUR 15.0 LUX
 - LIGHTING CONTOUR 20.0 LUX

Rev	Date	Description	Prod.	Chk.	Rev.	App.
P01	11/11/24	FIRST ISSUE	GJ	SD	MG	MG

Rev	Date	Description	Prod.	Chk.	Rev.	App.
P01	11/11/24	FIRST ISSUE	GJ	SD	MG	MG

VALE OF GLAMORGAN
BRO MORGANWIG

Project: Biglis to Dinas Powys ATR

Site: Biglis to Dinas Powys Cardiff
Client: Vale of Glamorgan Council Civic Offices, Holford Rd, Barry CF83 4RU www.valeofglamorgan.gov.uk

ARCADIS

Registered office: 80 Fenchurch Street, London EC3M 4BY
Coordinating office: Arcadis Suite 4d, 4th Floor, Hodge House, 144-166 St Mary St, Cardiff CF10 1DY Tel: 44 (0)29 2092 6700

www.arcadis.com © Copyright reserved

PROPOSED STREET LIGHTING LAYOUT SHEET 6

Designed	Signed	Date
J.C. Chambers	Digitally Signed	02/10/24
Produced	Signed	Date
G. Jones	Digitally Signed	08/11/24
Checked	Signed	Date
S. Davies	Digitally Signed	08/11/24
Reviewed	Signed	Date
M. Griffiths	Digitally Signed	11/11/24
Approved	Signed	Date
M. Griffiths	Digitally Signed	11/11/24

Design Stage: Preliminary Design

Original Size: A1 Grid: OS Datum: ODN
Suitability Code: S1 Scale: 1:500 Project Number: 10058585
Suitability Description:

Suitable for Coordination

Drawing Number: 10058585 - ARC - XX - 130 - DR - C - 00006
Revision: P01

CUTLINE - FOR CONTINUATION SEE SHEET 5 of 9